

4

3

2

1

D

D

C



C

B

B

A


A

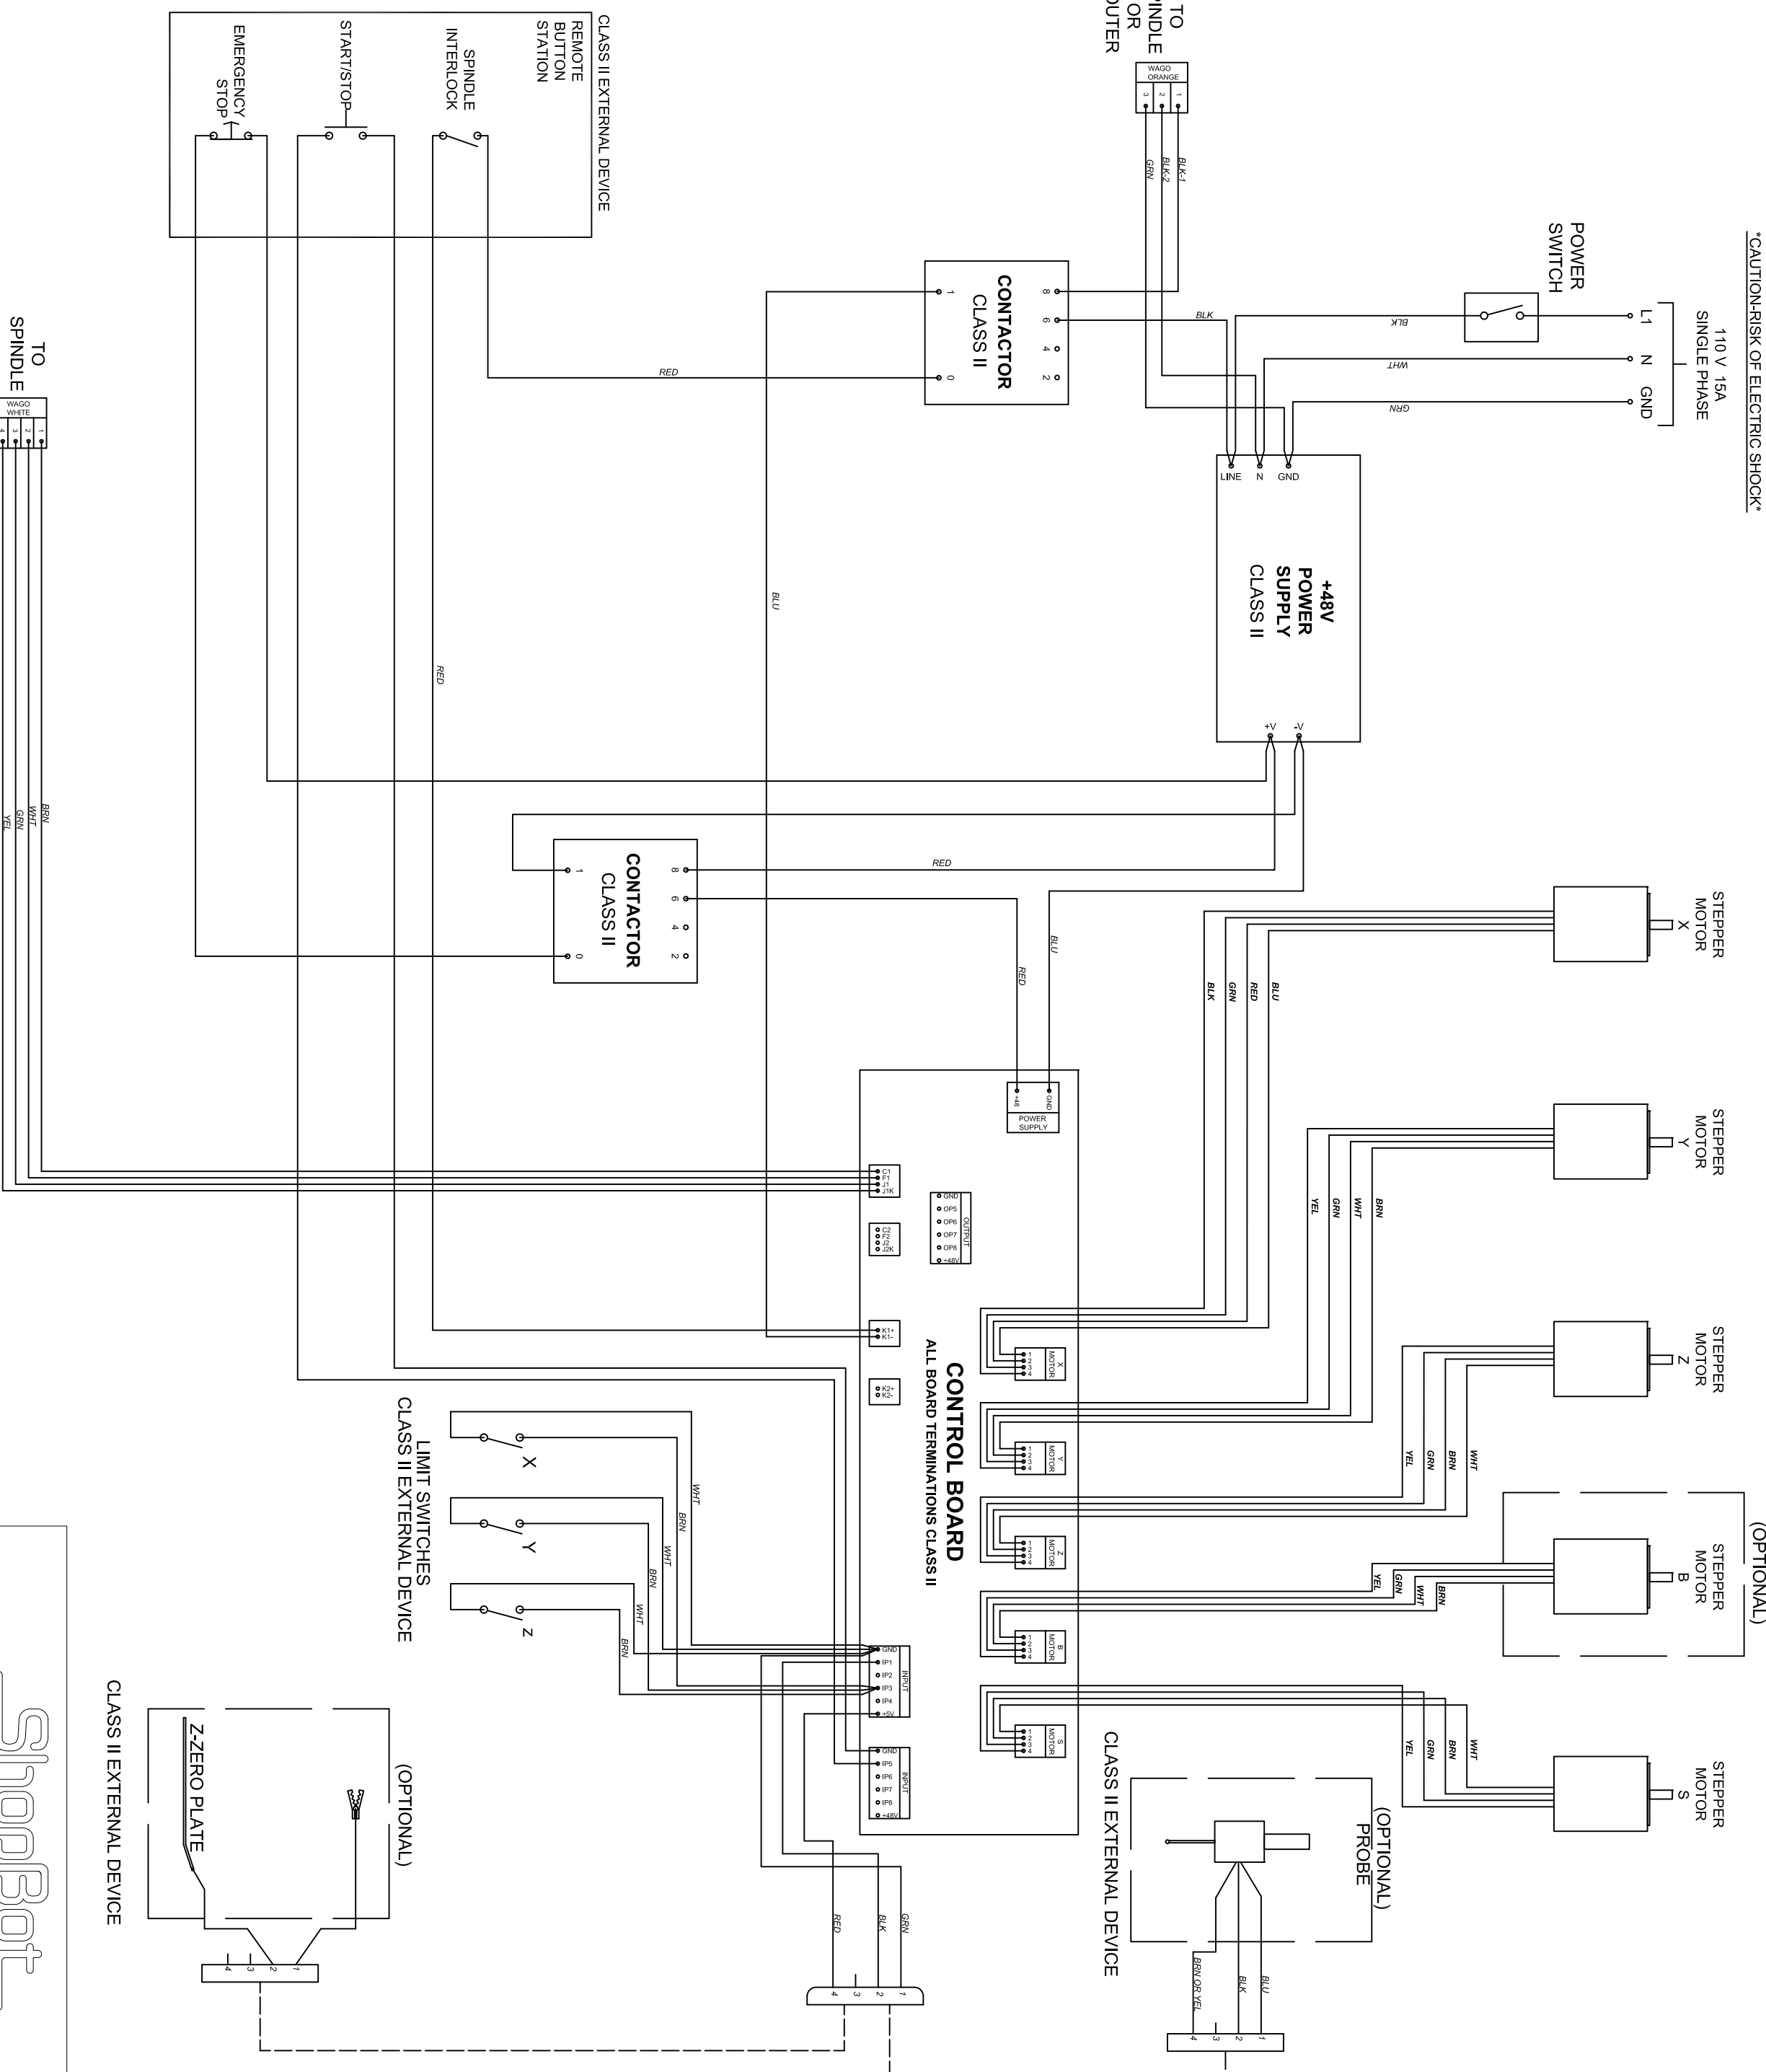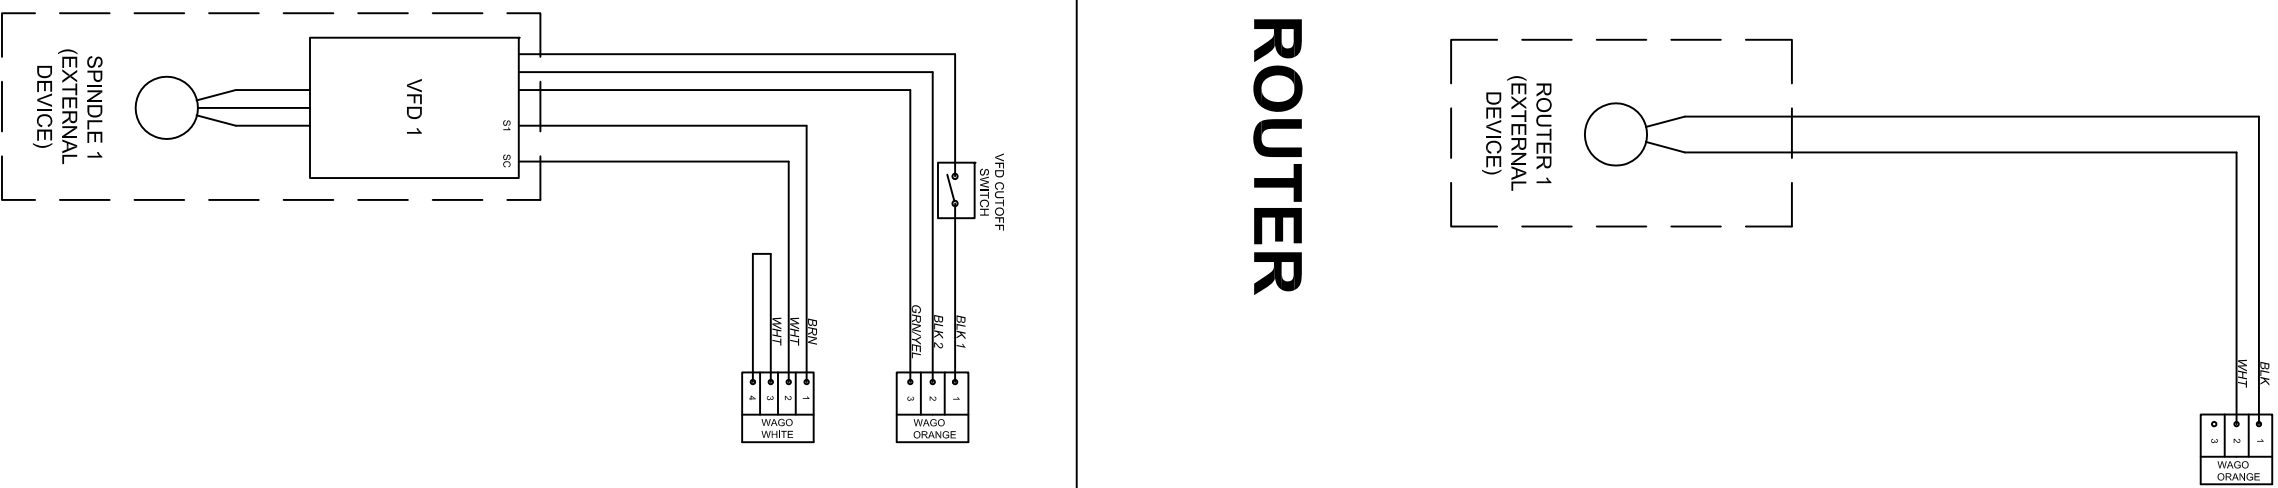

# CONTROL DIAGRAM - D3624/D2418

## SPINDLE

REV	0	CHG NOTICE	X	18JUL17	DATE	KWP	ADDED ROUTER OPTION FOR DT3 TOOLS	REVISION DESCRIPTION	4
REV	0	CHG NOTICE				APVD			4

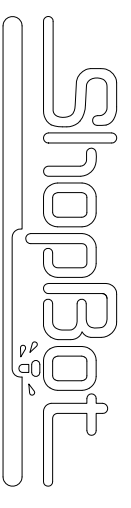

Durham, North Carolina

CONTROL DIAGRAM-D3624/D2418

TITLE	CONTROL DIAGRAM-D3624/D2418	
DRAWN	DATE	CHECKED
KWP	8/29/16	
SIZE	DRAWING NUMBER	APPROVED
C	005084-00	
PART NUMBER	005084-00	SHEET 1 OF 1
REV	0	DATE

DIM UNITS: MM SCALE: NONE  
 THIS DOCUMENT CONTAINS CONFIDENTIAL INFORMATION OF SHOPBOT TOOLS, IT IS NOT TO BE REPRODUCED BY ANY MEANS OR USED TO FURNISH INFORMATION TO OTHERS WITHOUT THE EXPRESS CONSENT OF THE OWNER. THE INFORMATION SHALL BE USED BY RECIPIENTS ONLY AS EXPRESSLY APPROVED BY OWNER AND THIS DOCUMENT SHALL BE RETURNED TO OWNER UPON REQUEST.  
 ©2008 SHOPBOT TOOLS, INC.  
 ALL RIGHTS RESERVED